


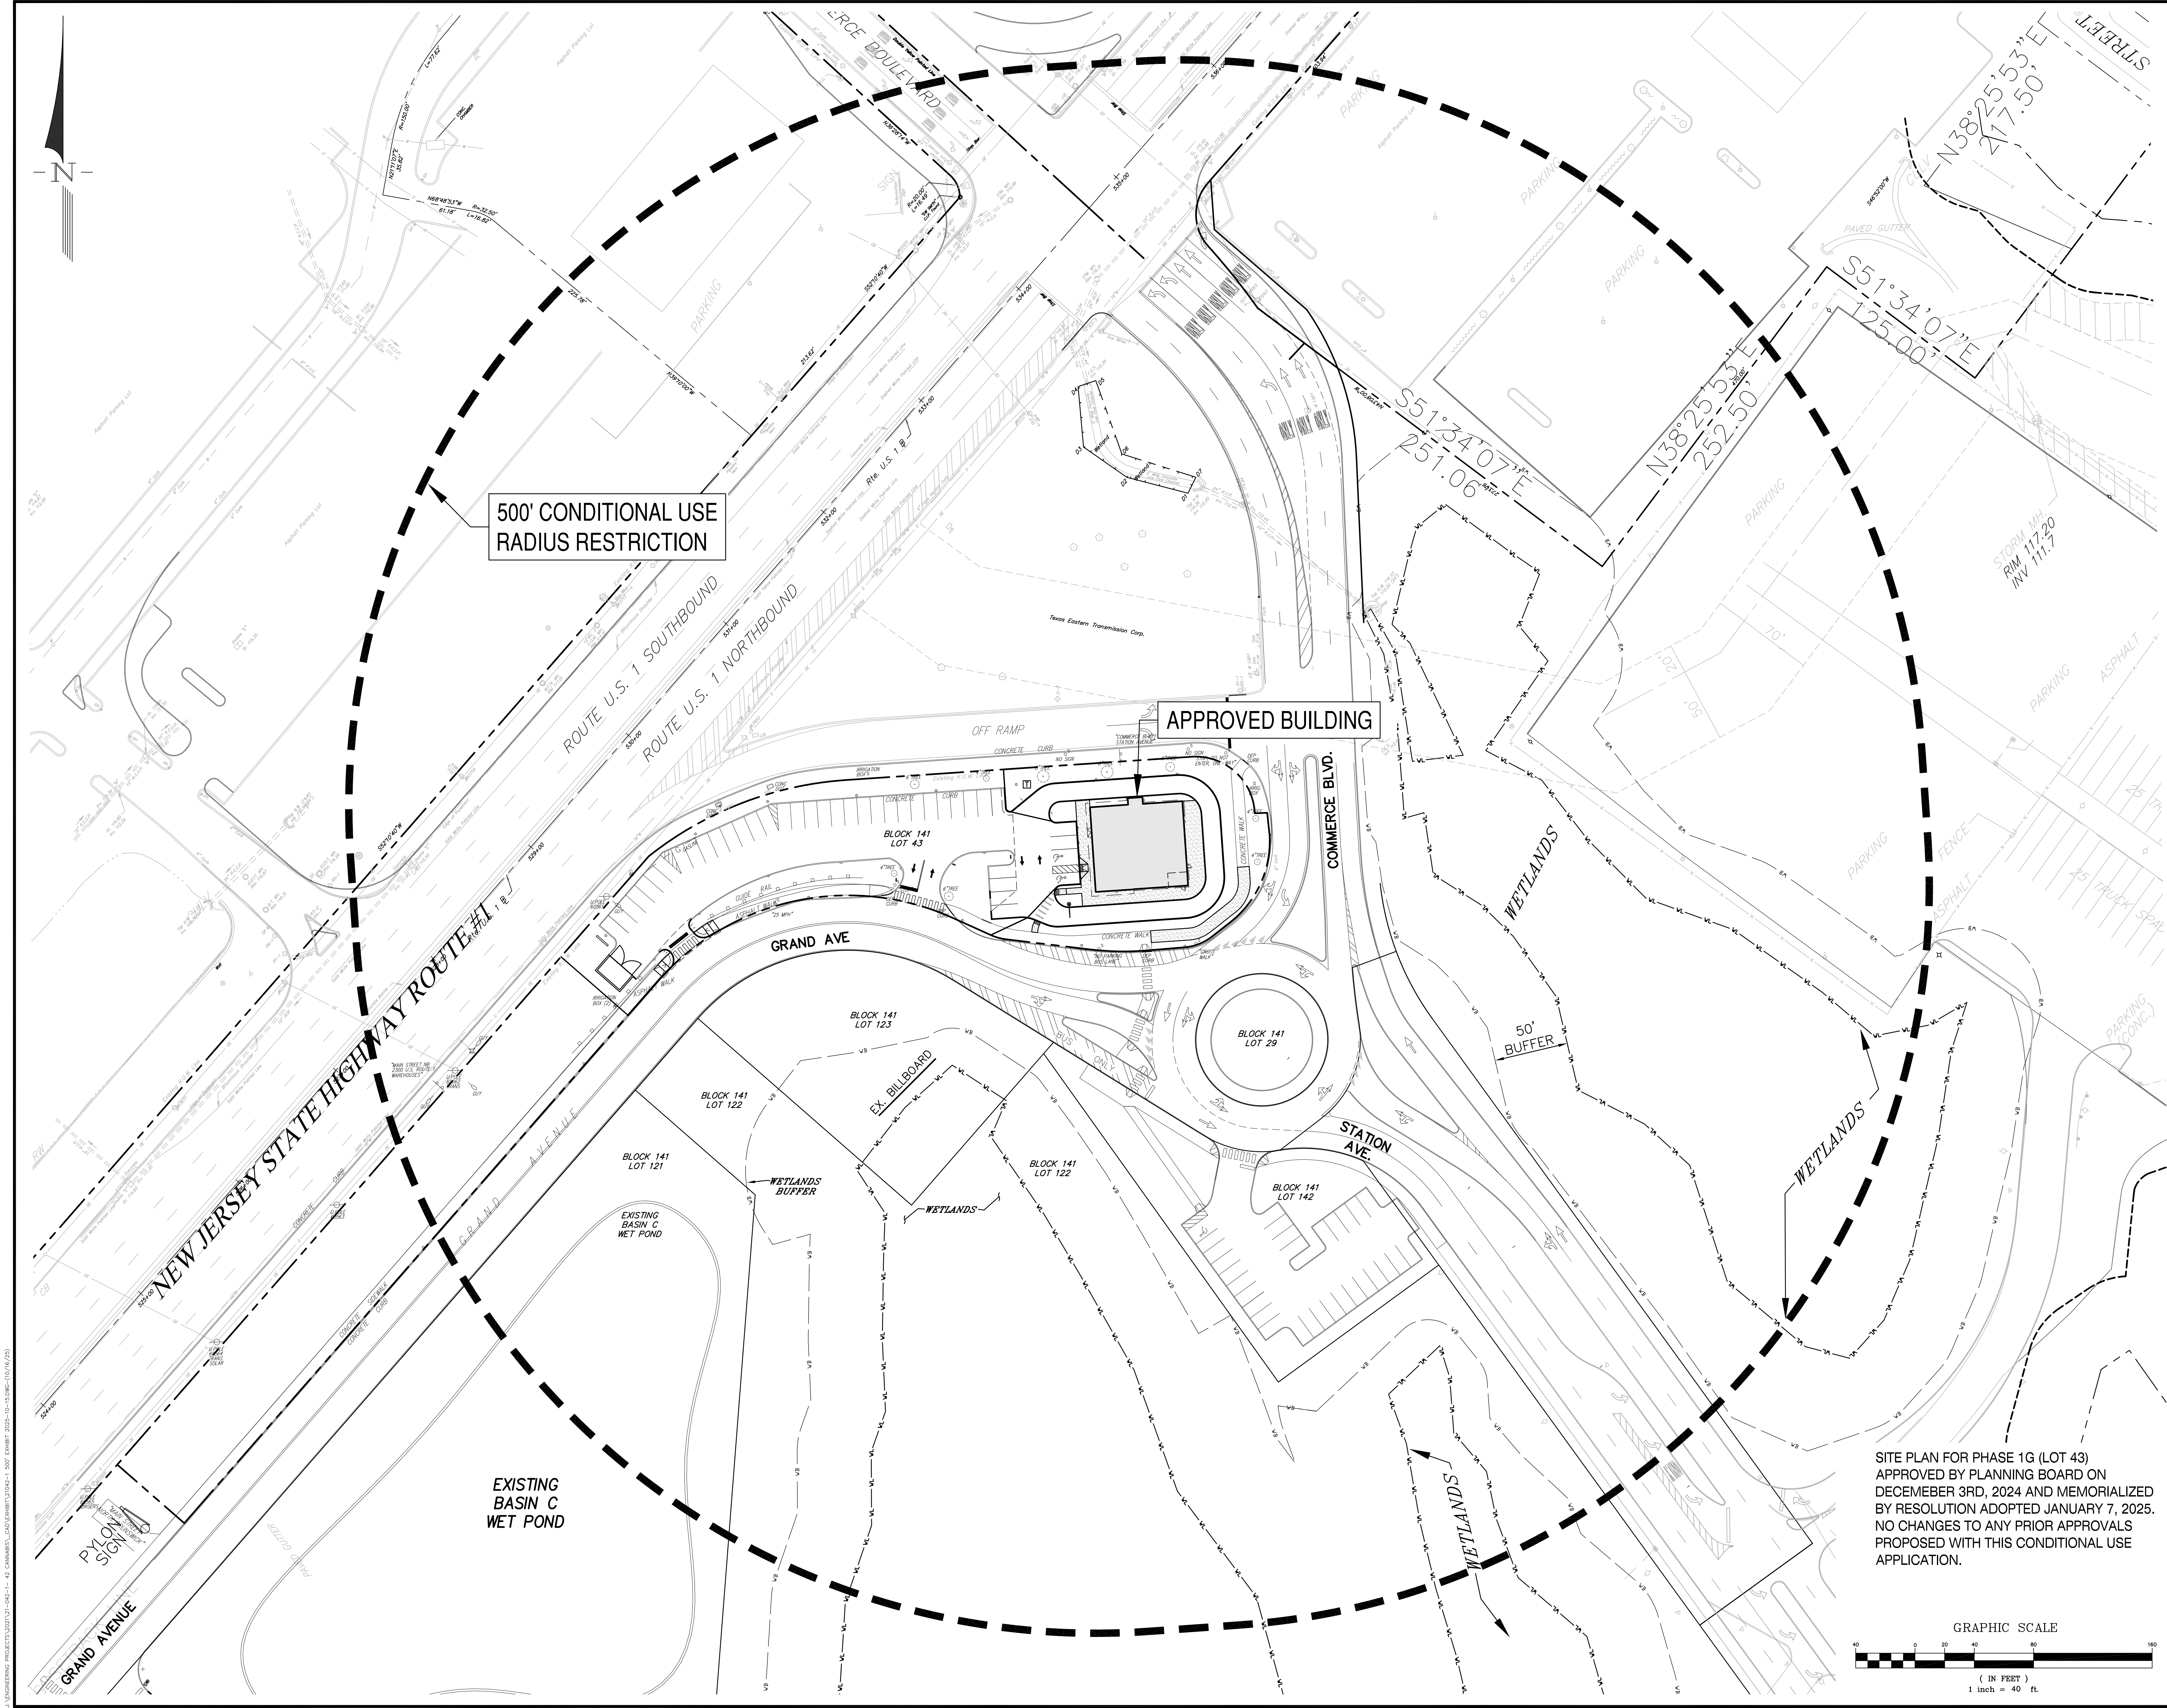


revisions		
no.	date	description


EXISTING LEGEND

- GAS VALVE
- GAS METER
- WATER VALVE
- HYDRANT
- WATER METER
- CURB STOP
- FIRE DEPT. CONNECTION
- DRAINAGE MH
- CURB INLET
- LAWN INLET
- SANITARY MH
- CLEANOUT
- BOLLARD
- SIGN
- LIGHT
- MAIL BOX
- GUY WIRE
- UTILITY POLE
- ELECTRIC MH
- CONIFEROUS TREE
- DECIDUOUS TREE
- FENCE
- RAILING
- WALL
- GATE POST
- WATER LINE
- GAS LINE
- ELECTRIC LINE
- SANITARY LINE
- OVERHEAD WIRES

PROPOSED LEGEND

- PHASE LINE
- STORM MANHOLE
- STORM 'B' INLET
- STORM 'E' INLET
- STORM LAWN INLET
- STORM PIPE
- SANITARY MANHOLE
- SANITARY PIPE
- WATER LINE
- WATER VALVE
- FIRE HYDRANT
- F.D.C.
- STREET SIGN

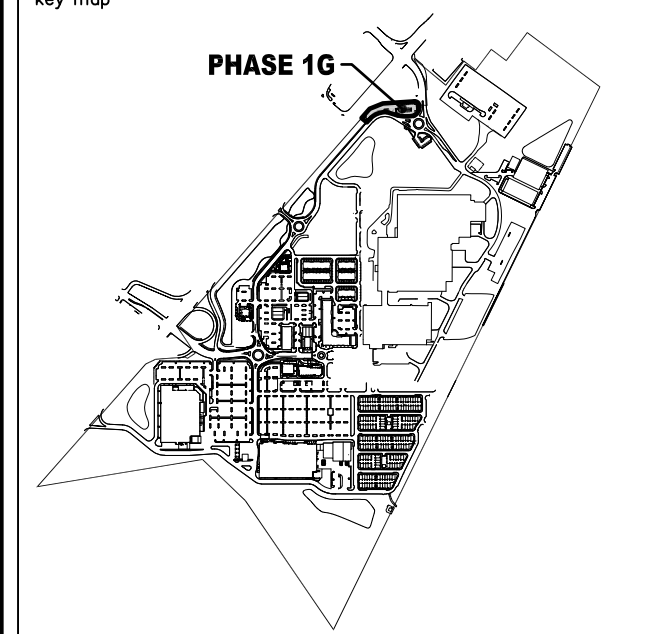

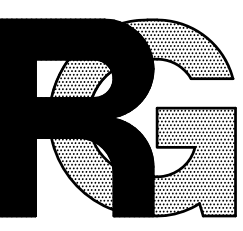

Engineers
Landscape Architects
Land Surveyors
Planners

575 Route 28, Suite 110
Bridgeton, N.J. 08619
908-722-1500
Fax 908-722-7035
www.reynoldsgroup.com

The Reynolds Group Inc.

State of New Jersey
Certificate of Authorization
Number: 240A27989200
21MH00004300

F. Mitchell Ardman, P.E., P.P.
Jeffrey D. Reynolds, P.L.A.

F. MITCHEL ARDMAN
N.J. PROFESSIONAL ENGINEER LIC. NO. 34317

**CONDITIONAL USE APPLICATION
EXHIBIT A**

**BLOCK 141, LOT 43
NORTH BRUNSWICK TOWNSHIP
MIDDLESEX COUNTY, NEW JERSEY**

**CANNABIS -
CONDITIONAL USE
RADIUS RESTRICTION
EXHIBIT**

job number 21-042-1	drawing number 1
scale 1"=40'	
checked by FMA/AEC	
drawn by A.A.	
date 10/15/25	sheet 1 of 1

SITE PLAN FOR PHASE 1G (LOT 43)
APPROVED BY PLANNING BOARD ON
DECEMBER 3RD, 2024 AND MEMORIALIZED
BY RESOLUTION ADOPTED JANUARY 7, 2025.
NO CHANGES TO ANY PRIOR APPROVALS
PROPOSED WITH THIS CONDITIONAL USE
APPLICATION.

GRAPHIC SCALE
(IN FEET)
1 inch = 40 ft.